



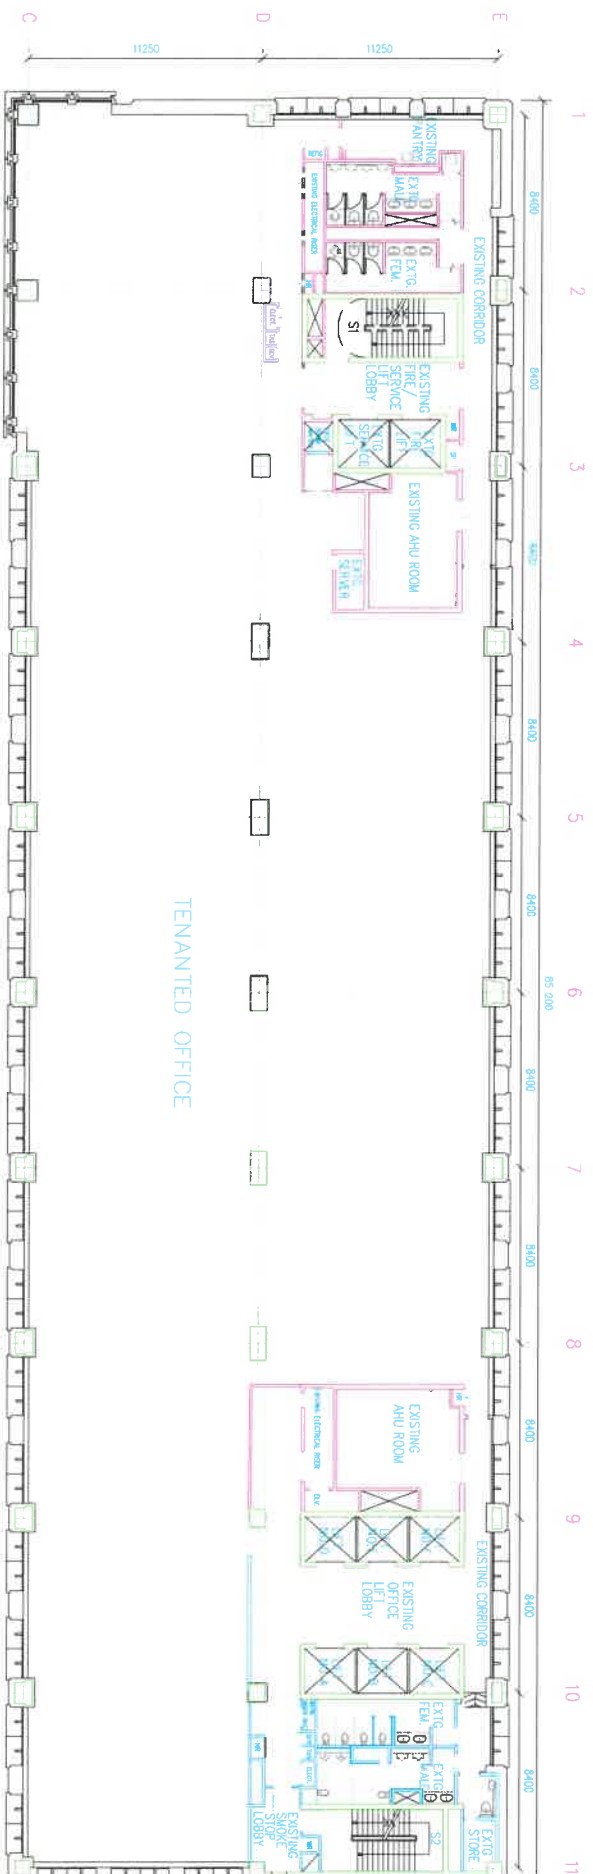


7TH TO 9TH STOREY PLAN

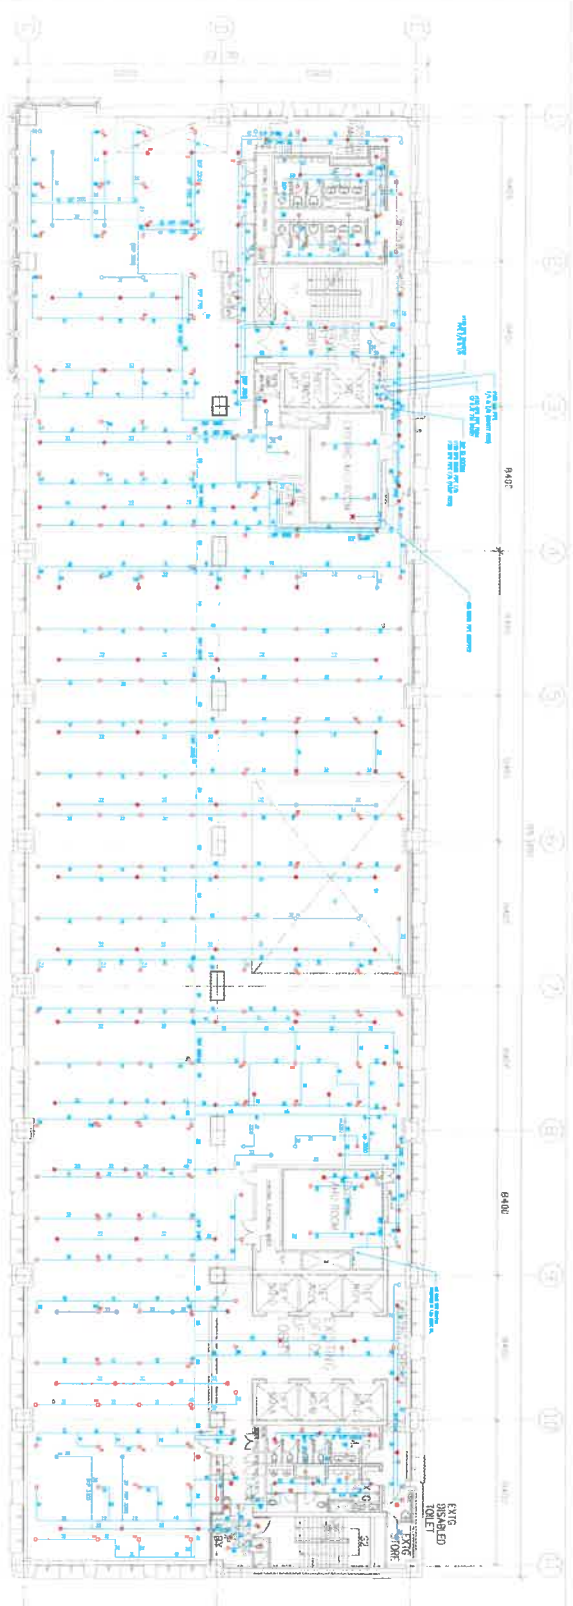

5TH STOREY PLAN

NO. OF PERSONS PROVIDED WITH MEANS OF ESCAPE 300
THIS FLOOR IS PROTECTED BY SPRINKLER SYSTEM

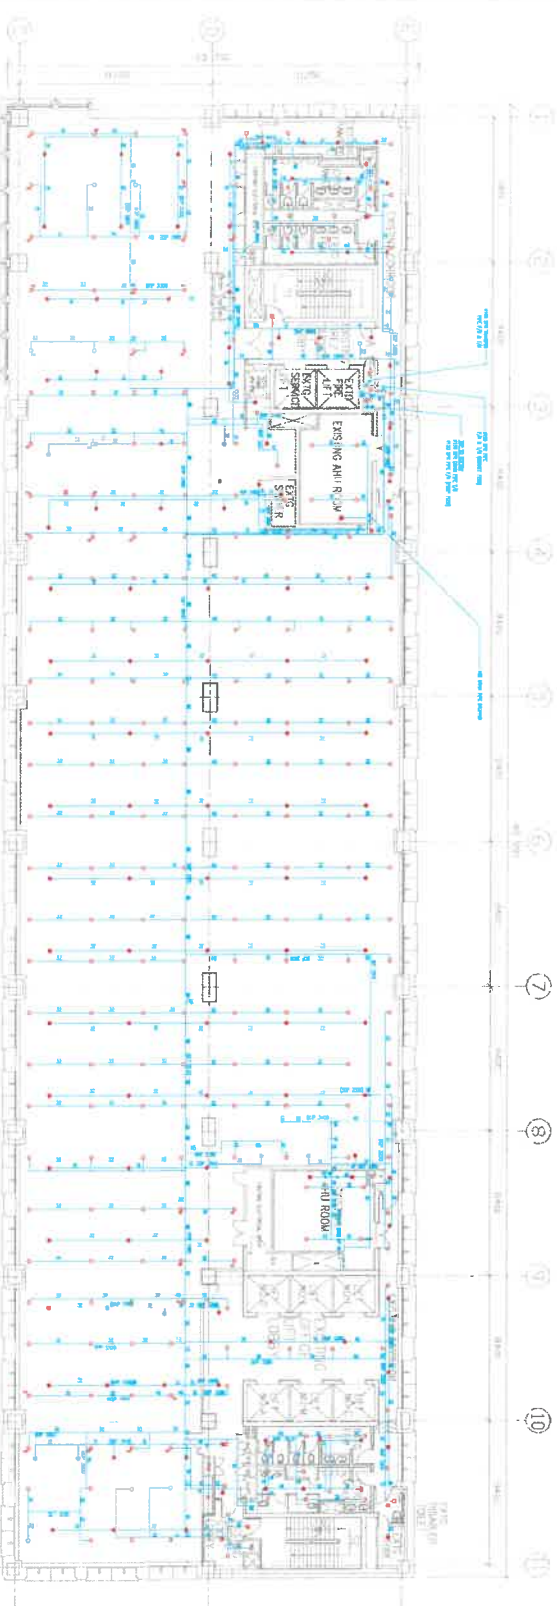

7TH STOREY PLAN

SCALE = 100

- LEGEND:**
- 1. FIRE EXTINGUISHING R.I.U.
 - 2. FIRE EXTINGUISHING R.I.U.
 - 3. FIRE EXTINGUISHING R.I.U.
 - 100. FIRE EXTINGUISHING R.I.U.

AS-BUILT

PROPOSED ADDITION & ALTERATIONS
TO EXISTING BUILDING WITH BASEMENT
OFFICE BUILDING WITH BASEMENT
BASEMENT & ROADS (KAWANANUI
STREET)

URBAN
REDEVELOPMENT
AUTHORITY



Lincoln Scott Ng
ARCHITECT

SHAW WOODWARD CONSULTING LTD
ENGINEERS

7TH-8TH STOREY PLAN
(SPRINKLER LAYOUT)

Glass Door (Location 1) - To remove and repurposed (1 leaf with handle) for Location (4) - Put up dry wall - Walls to be painted in same/matching colour as URA existing wall Glass Door (Location 2) - To be removed - Put up dry wall - Reuse door from ED/Chairman's room (from L7) - Walls to be painted in same/matching colour as URA existing wall	Main Entrance  ED/Chairman's Room Doors (from L7) 
To put up wooden door provided by CLC Ltd	Wooden Door (micronic lift) 
Glass walls at corridor near micronic lift (Location 3) - To remove - Put up dry wall - Walls to be painted same/matching colour as URA existing wall Glass Door and Frame (Location 4) - to remove - to install glass door (1 leaf with handle) from Location 1	Corridor (Micronic Lift) 
Whiteboard in Training Rooms (Location 5 and 6) - to remove whiteboards and make good the walls - walls to remain as NSCS office is next door	Whiteboard in Training Rooms 
Glass doors along URA common corridor - to remove - put up dry wall - walls to be painted same/matching colour as URA existing wall	Common Corridor (leading to NSCS) 
To remove: - Internal walls - Operable wall	Furniture & Fixtures

 - Internal doors - Secom access units, keyholes, emergency access points - Cabinets - Projectors	Blinds		To remain		Ceiling	- Ceiling boards to remain - False ceiling to be removed and left bare.	To remove and clean	To remove		Exit Sign		To relocate/remove		Aircon (Server Room)   - To remove indoor aircon units for retention - To remove outdoor condenser units (located at L5 podium roof top) for retention - To remove piping that runs from condensers located at L5 podium roof top to L8 server room - To remove piping in riser - To reinstate damaged URA ceiling boards along common passageway upon removal of CLC Ltd's condenser & related piping	To quote as OPTIONAL item

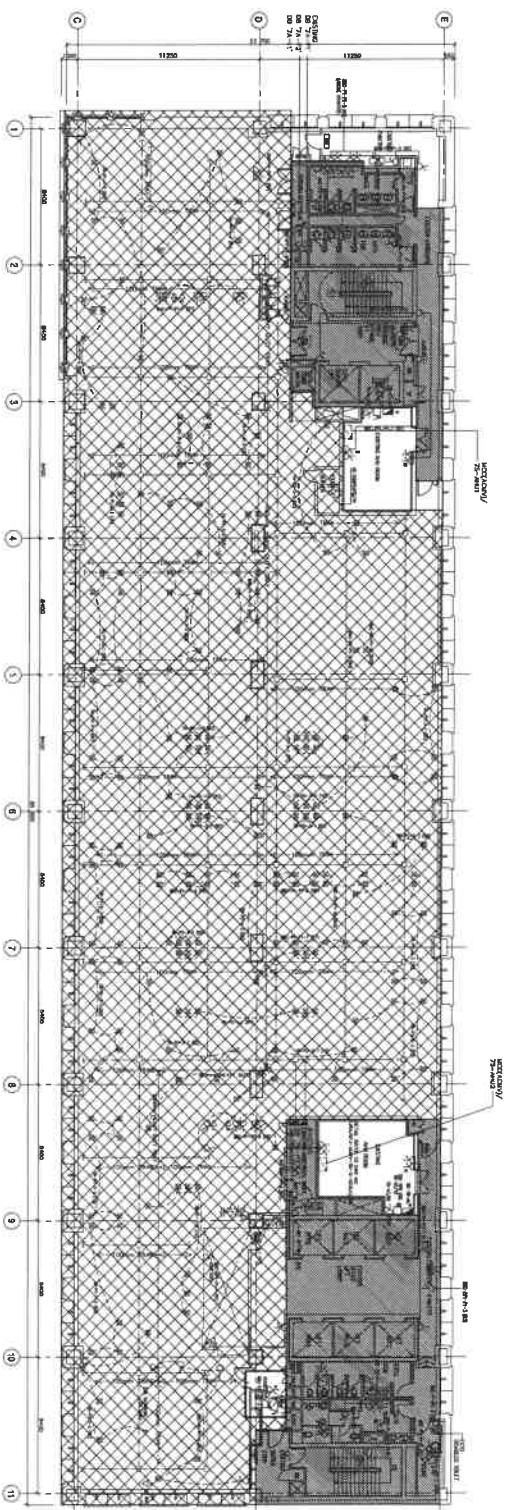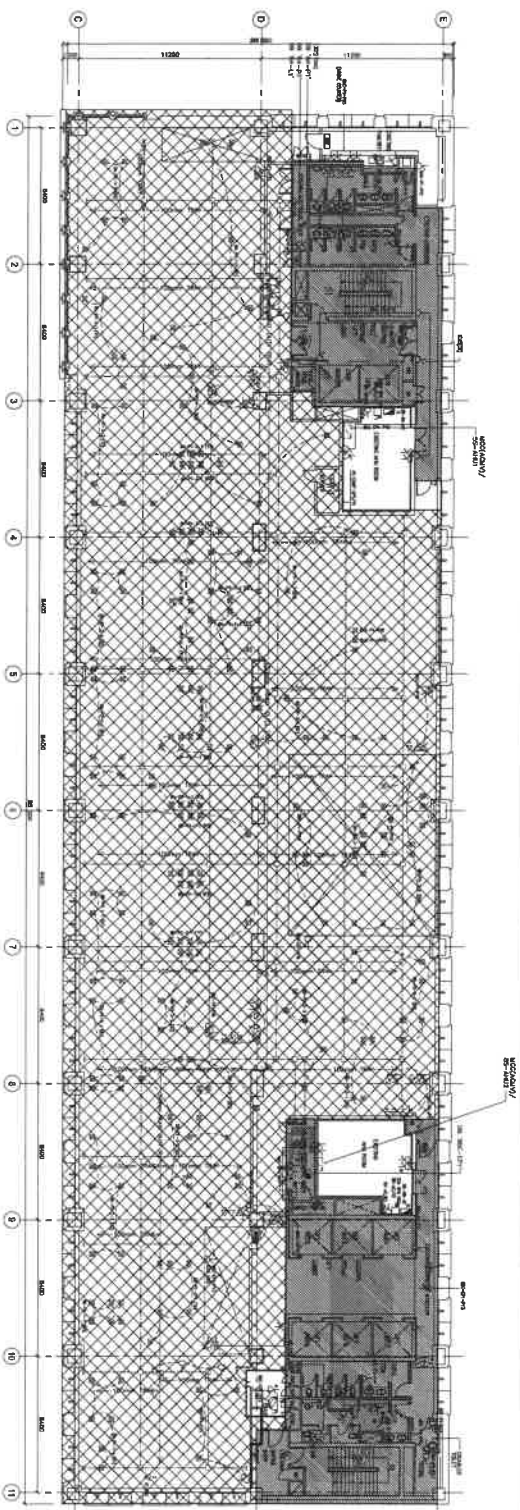

AS-BUILT DRAWING

Date : 10 MAY 2010

ARCHITECT DRAWG.: JULY 2000

TELEVISION RECORD

REV	AMENDONED
-----	-----------

**PROPOSED ADDITIONS & ALTERATIONS
TO EXISTING URA CENTRE (16 STOREY
OFFICE BUILDING WITH 2 BASEMENT
CARPARK) ON LOT 006890, TS 3 AT
MAXWELL ROAD, KADAYANALLUR
STREET**

OWNER :



URBAN
REDEVELOPMENT
AUTHORITY

To make Singapore a great city to live, work and play a

Lincolne Scott Ng

Consulting Engineers
Available Asbestos Consultants
Bakulnari Civils Contractors
Hortelau Mahoness Parn
Sani Design Singapore Sydney

MAIN CONTRACTOR :


 **SUNRAY WOODCRAFT CONSTRUCTION PTE LTD**
2027 Bukit Merah St. 23, Singapore 659632
Tel: 65962311 Fax: 65963332
EMAIL: sunray_construction@sunray.sg

SUBJECT OF DRAWING :
ELECTRICAL INSTALLATION
POWER & CABLE ROUTING LAYOUT
7TH & 8TH STOREY PLAN

FILENAME : SWC-06103-E209	
SCALE : 1:150	DATE : 31 AUG 2009
DRAWN : AL	CHECKED : MOHD SY /

DRAWING NO: SWC/08103/E209

UNLESS OTHERWISE NOTED, COPYRIGHT IN THIS OFFERING BELONGS TO THE ARCHITECTS
PLANNERS & DESIGNERS (P+D) LTD. THIS OFFERING MAY NOT BE REPRODUCED IN WHOLE OR

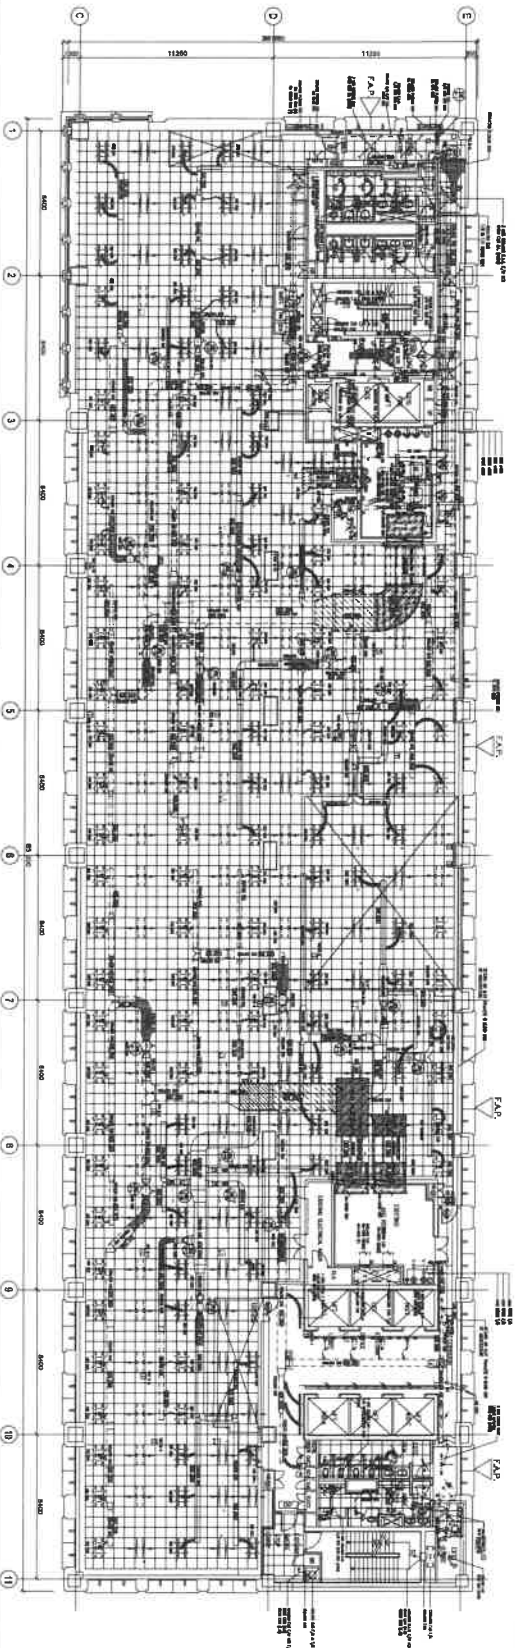

8TH STOREY EQUIPMENT SCHEDULE

SCHEDULE OF EQUIPMENT AT COX

NO.	DESCRIPTION	QTY	UNIT	REMARKS
1	1.1	1	1	1.1
2	2.1	1	1	2.1
3	3.1	1	1	3.1
100	100.1	1	1	100.1

8TH STOREY EQUIPMENT SCHEDULE

SCHEDULE OF EQUIPMENT AT COX

NO.	DESCRIPTION	QTY	UNIT	REMARKS
1	1.1	1	1	1.1
2	2.1	1	1	2.1
3	3.1	1	1	3.1
100	100.1	1	1	100.1

8TH STOREY PLAN

NO OF COX = 4 NOS

NO.	DESCRIPTION	QTY	UNIT	REMARKS
1	1.1	1	1	1.1
2	2.1	1	1	2.1
3	3.1	1	1	3.1
100	100.1	1	1	100.1

APPROVED PLAN
Date of submission : 16-03-2009
Approval Date : 30-03-2009

Date

Applicant/Owner

**URBAN
REDEVELOPMENT
AUTHORITY**

To make Singapore a great city to live, work and play in.

Design by
Project One

7TH & 8TH STOREY PLAN

Eastman Kodak	
---------------	--

SALT CHINA
PL-b-charge

DO PROJECTS I